

**KEY NOTES**

- 27 CONNECTION TO ELEVATOR OIL MINDER HIGH WATER PUMP. COORDINATE WIRING REQUIREMENTS WITH MANUFACTURER'S RECOMMENDATIONS. COORDINATE OIL MINDER PUMP AND ALARM CONTROL PANEL LOCATION WITH MECHANICAL CONTRACTOR AND OWNER PRIOR TO INSTALLATION.
- 28 CONNECTION TO ELEVATOR SUMP PUMP. COORDINATE WIRING REQUIREMENTS WITH MANUFACTURER'S RECOMMENDATIONS. COORDINATE PUMP LOCATION WITH MECHANICAL CONTRACTOR AND OWNER PRIOR TO INSTALLATION.
- 30 1" DIRECT BURIED CONDUIT FOR CONNECTION TO SEPTIC PUMP AND ALARM CONTROL PANEL. ROUTING TO BE PER CIVIL PLANS TO ELECTRICAL ROOM 123.
- 78 OUTLETS TO BE INSTALLED IN BUILT STAGE STAIR FACE FOR SCORER'S TABLE CONTROLLER.


HENDERSON COUNTY SCHOOLS  
**EDNEYVILLE ELEMENTARY SCHOOL**  
 2875 FACE ROAD  
 HENDERSONVILLE, NC 28792

DESIGNER  
**CLARK NEXSEN**  
 301 College Street, Suite 300  
 Asheville, North Carolina 28801  
 828-232-0008  
 www.clarknexsen.com

SEALS  
  
 2018.11.21 14:36:38-05'00"  
 SUBMITTAL  
 06.04.2018  
**ISSUED FOR CONSTRUCTION**

REVISIONS


NO.	DATE	REVISION
8	10/25/18	Revision 8
9	11/21/18	Revision 9

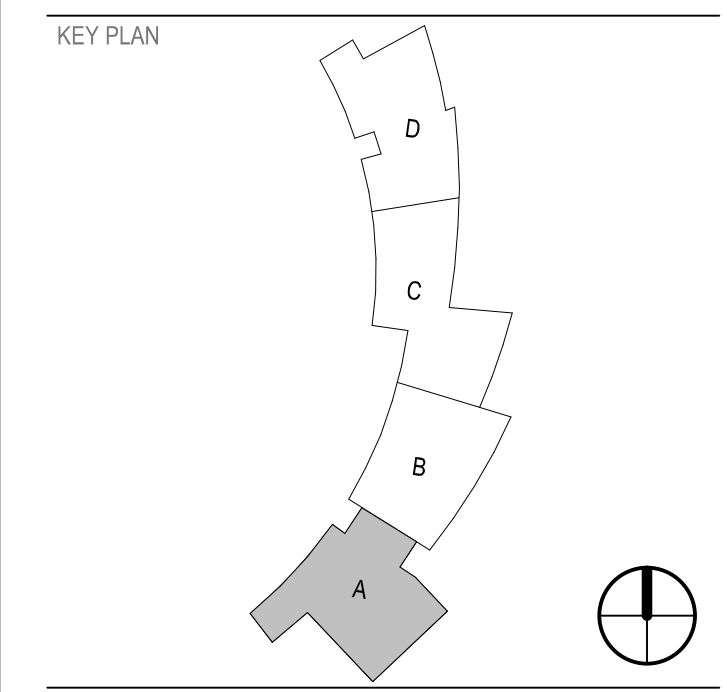

**RATED PARTITION LEGEND**

- ONE HALF HOUR FIRE RATING
- ONE HOUR FIRE RATING
- TWO HOUR FIRE RATING
- SMOKE BARRIER (SB), SMOKE PARTITION (SP), OR PARTITION CAPABLE OF RESISTING THE PASSAGE OF SMOKE (S)

 **GRAPHIC SCALE(S)**



**A1 LOWER LEVEL POWER PLAN - AREA A**  
 1/8" = 1'-0"

DESIGN: JAR  
 DRAWN: JAR  
 REVIEW: PJR  
 CN  
 5199.D

1/12/2018 2:35:29 PM  
 C:\Revit\Projects\191902\_Edneysville Elem E17\_jash\A1\A1.CAD