




# KEY NOTES

38 CONNECTION TO OUTDOOR UNIT-2 LOCATED ON THE ROOF.

HENDERSON COUNTY SCHOOLS  
**EDNEYVILLE  
 ELEMENTARY SCHOOL**  
 2875 PAGE ROAD  
 HENDERSONVILLE, NC 28792


DESIGNER  
**CLARK NEXSEN**  
 301 College Street, Suite 300  
 Asheville, North Carolina 28801  
 828-232-0608  
 www.clarknexsen.com

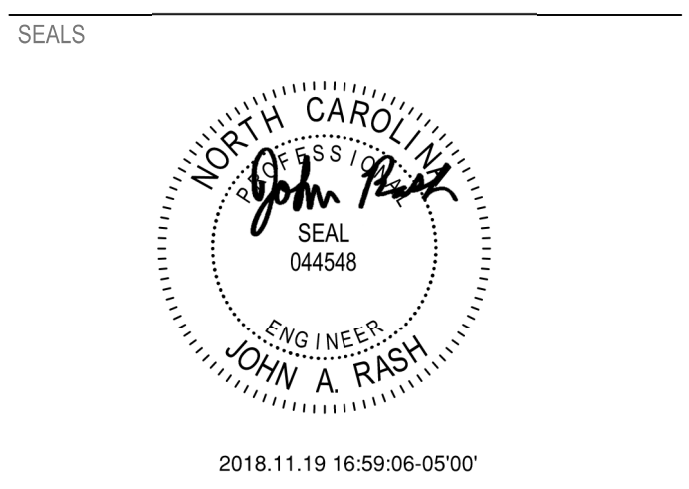

SUBMITTAL  
 06.04.2018  
**ISSUED FOR CONSTRUCTION**

REVISIONS


NO.	DATE	REVISION
9	11/21/18	Revision 9

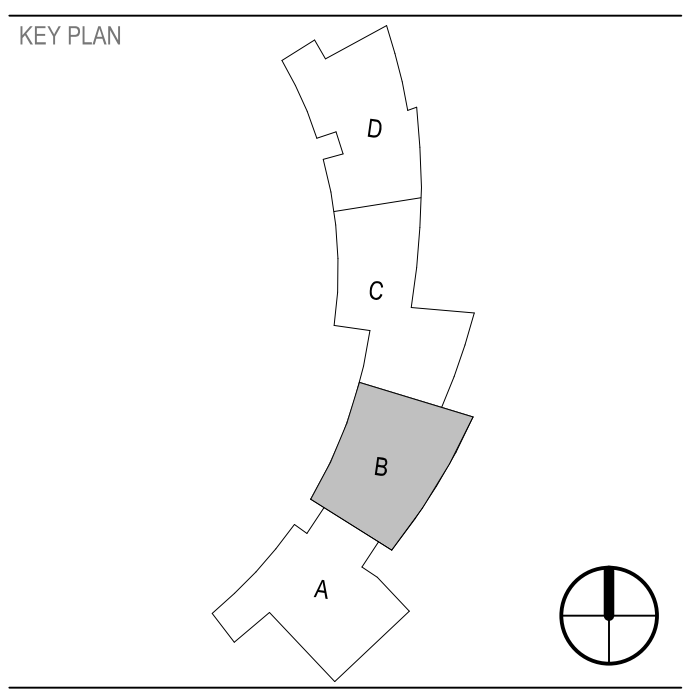

RATED PARTITION LEGEND

- ONE HALF HOUR FIRE RATING
- ONE HOUR FIRE RATING
- TWO HOUR FIRE RATING
- SMOKE BARRIER (SB), SMOKE PARTITION (SP), OR PARTITION CAPABLE OF RESISTING THE PASSAGE OF SMOKE (S)

 GRAPHIC SCALE(S)



**A1 LOWER LEVEL POWER PLAN - AREA B**  
 1/8" = 1'-0"

1/10/2018 4:55:33 PM  
 C:\Rent\Projects\19601\_Edneyville\_Elem E17\_jarsh\A1\A1.CAD

DESIGN: JAR  
 DRAWN: JAR  
 REVIEW: PJR

CN  
 5199.D