


- # KEY NOTES**
- 22 CONNECTION TO BASKETBALL WINCH. PROVIDE CONNECTION WITH NEMA CONFIGURATION PER MANUFACTURER'S RECOMMENDATION.
  - 23 CONNECTION TO SCOREBOARD CONTROLLER. COORDINATE FINAL LOCATION WITH HCPS PRIOR TO INSTALLATION.
  - 95 CONNECTION TO ELEVATOR CONTROLLER. COORDINATE FINAL LOCATION PRIOR TO INSTALLATION.
  - 150 PROVIDE INTERFACE WIRING AND RACEWAY FROM SHUNT TRIP TO FIRE ALARM SYSTEM AND AUX CONTACTS FROM SHUNT TRIP TO ELEVATOR CONTROLLER.

HENDERSON COUNTY SCHOOLS  
**EDNEYVILLE ELEMENTARY SCHOOL**  
 2875 FACE ROAD  
 HENDERSONVILLE, NC 28792


DESIGNER  
**CLARK Nexsen**  
 301 College Street, Suite 300  
 Asheville, North Carolina 28801  
 828-232-0608  
 www.clarknexsen.com

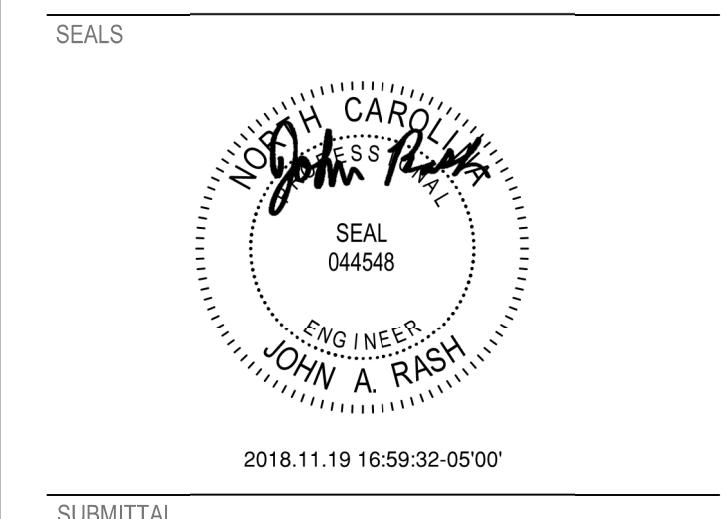

SUBMITTAL  
 06.04.2018  
**ISSUED FOR CONSTRUCTION**


REVISIONS

NO.	DATE	REVISION
1	06.04.18	Revision 1
8	10/25/18	Revision 8
9	11/21/18	Revision 9

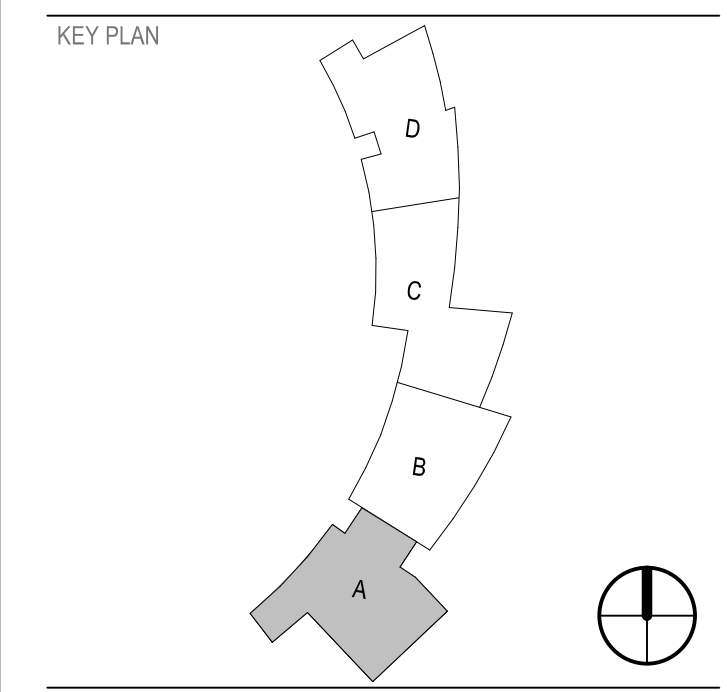

**RATED PARTITION LEGEND**

	ONE HALF HOUR FIRE RATING
	ONE HOUR FIRE RATING
	TWO HOUR FIRE RATING
	SMOKE BARRIER (SB), SMOKE PARTITION (SP), OR PARTITION CAPABLE OF RESISTING THE PASSAGE OF SMOKE (S)

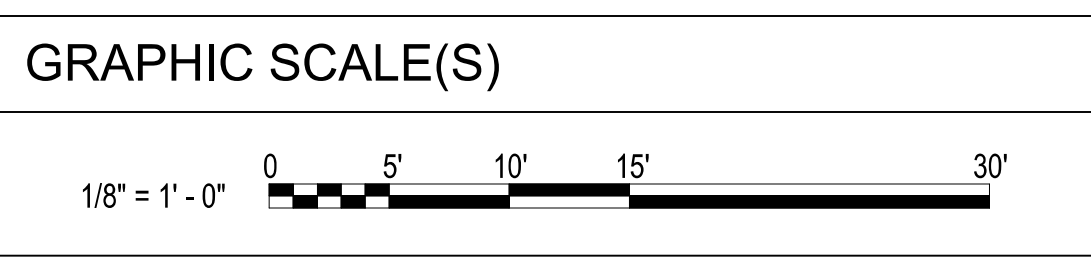

**A1 MAIN LEVEL POWER PLAN - AREA A**  
 1/8" = 1'-0"

SHEET  
**MAIN LEVEL POWER PLAN - AREA A**  
**EP103**  
 DESIGN: JAR  
 DRAWN: JAR  
 REVIEW: PJR  
 CN  
 5199.D

1/15/2018 4:55:39 PM  
 C:\Revit\Projects\191901\_Edneyville\_Elem\EP103\Area A.rvt