

(A1) MAIN LEVEL POWER PLAN - AREA B
1/8" = 1'-0"

 
KEY NOTES

- 15 1" CONDUIT TO BE RUN UNDER SLAB AND TURN UP AT NEAREST FULL WALL HIDDEN FROM VIEW TO ELECTRICAL ROOM. COORDINATE DIRECT ROUTING WITH STRUCTURAL ELEMENTS.
- 12 CONNECTION TO MECHANICAL CONDENSING UNITS.
- 13 CONNECTION FOR DCU POWER SUPPLY. DIVISION 26 TO PROVIDE 1/2" CONDUIT 2 TO EACH DCU.
- 14 MOUNT RECEPTACLE AT 36" FOR MICROWAVE IN CASEWORK. COORDINATE WITH CASEWORK PRIOR TO INSTALLATION.

RATED PARTITION LEGEND

- ONE HALF HOUR FIRE RATING
- ONE HOUR FIRE RATING
- TWO HOUR FIRE RATING
- SMOKE BARRIER (SB), SMOKE PARTITION (SP), OR PARTITION CAPABLE OF RESISTING THE PASSAGE OF SMOKE (S)

GRAPHIC SCALE(S)



HENDERSON COUNTY SCHOOLS
**EDNEYVILLE
ELEMENTARY SCHOOL**
2875 PAGE ROAD
HENDERSONVILLE, NC 28792

DESIGNER
CLARK Nexsen
301 College Street, Suite 300
Asheville, North Carolina 28801
828-232-0606
www.clarknexsen.com


SEALS

2018.10.25 16:15:16-04'00"

SUBMITTAL
06.04.2018
ISSUED FOR CONSTRUCTION

REVISIONS

NO.	DATE	REVISION
8	10/25/18	Revision 8

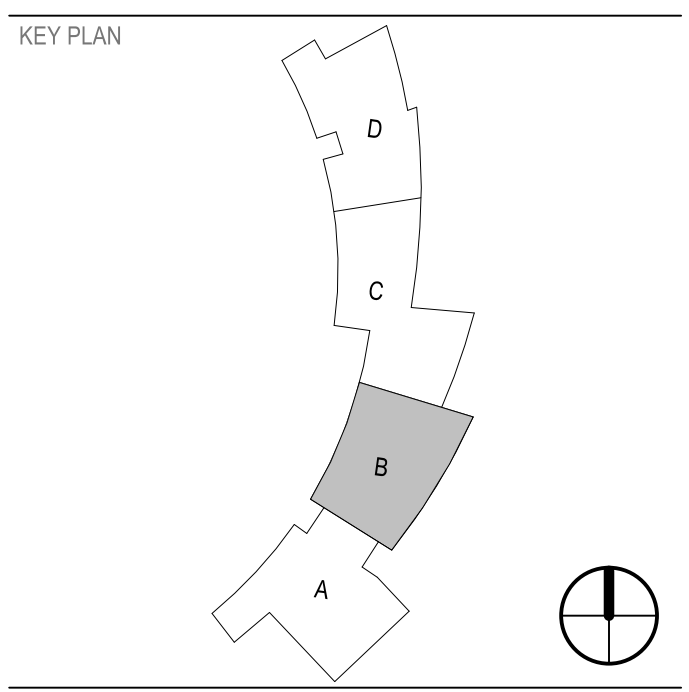

SHEET
MAIN LEVEL POWER PLAN - AREA B

EP104

DESIGN: JAR
DRAWN: JAR
REVIEW: PJR
CN
5199.D

10/25/2018 4:13:06 PM
C:\Revit\Projects\18010_Edneyville_Elem E17_jash\A1\A1.dwg