

**A1 MAIN LEVEL POWER PLAN - AREA D**  
1/8" = 1'-0"

**# KEY NOTES**

- 29 CONNECTION TO WATER HEATER CONTROLLER. MAXIMUM OF 4 WATER HEATERS PER CIRCUIT.
- 31 1" DIRECT BURIED CONDUIT FROM PANEL 1NL9 IN PREP (512) TO SERVING LINE HOT AND COLD STATIONS. COORDINATE WITH CIVIL PLANS AND STRUCTURAL ELEMENTS. COORDINATE NEMA CONFIGURATION WITH MANUFACTURER PRIOR TO INSTALLATION.
- 34 CONNECTION TO MOTOR DOOR CONTROLLER SWITCH. PROVIDE 3/4" CONDUIT FOR UP/DOWN CONTROL. COORDINATE LOCATION OF UP/DOWN CONTROL SWITCH AND WIRING WITH DOOR MANUFACTURER PRIOR TO INSTALLATION.
- 120 CONNECTION FROM OUTDOOR UNIT ON ROOF.
- 124 FREEZER CONDENSING UNIT CONNECTION. COORDINATE FINAL LOCATION WITH ARCHITECTURAL PLANS PRIOR TO INSTALLATION.
- 125 COOLER CONDENSING UNIT CONNECTION. COORDINATE FINAL LOCATION WITH ARCHITECTURAL PLANS PRIOR TO INSTALLATION.

HENDERSON COUNTY SCHOOLS

**EDNEYVILLE  
ELEMENTARY SCHOOL**


2875 PAGE ROAD  
HENDERSONVILLE, NC 28792

DESIGNER

**CLARK NEXSEN**

301 College Street, Suite 300  
Asheville, North Carolina 28801  
828-232-0609  
www.clarknexsen.com

SEALS

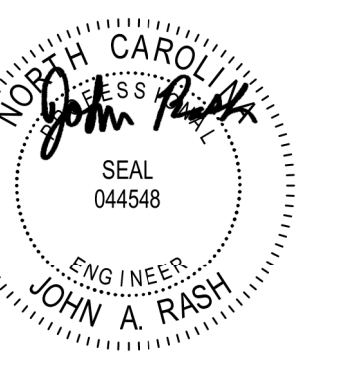

2018.11.19 17:00:49-05'00'

SUBMITTAL


06.04.2018

**ISSUED FOR CONSTRUCTION**

REVISIONS

NO.	DATE	REVISION
1	06.04.18	Revision 1
8	10/25/18	Revision 8
9	11/21/18	Revision 9

KEY PLAN

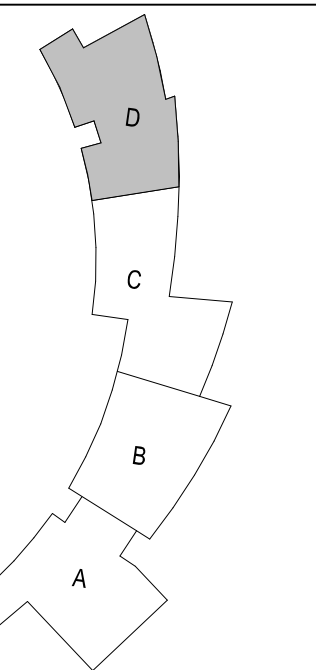

SHEET

**MAIN LEVEL POWER PLAN -  
AREA D**

**EP106**

DESIGN: JAR  
DRAWN: JAR  
REVIEW: PJR

CN  
5199.D

**RATED PARTITION LEGEND**

- ONE HALF HOUR FIRE RATING
- ONE HOUR FIRE RATING
- TWO HOUR FIRE RATING
- SMOKE BARRIER (SB), SMOKE PARTITION (SP), OR PARTITION CAPABLE OF RESISTING THE PASSAGE OF SMOKE (S)

**GRAPHIC SCALE(S)**



1/10/2018 4:55:48 PM C:\rent\Projects\191901\_Edneysville\_Elem\EP106\AreaD\A1.dwg